



**SITE PLAN**  
 scale 1:200

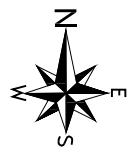

PROPOSED SHOP-FITTING  
 shop 7 (LOT12) Brisbane Street, Perth



**MO DESIGN**  
 P O BOX 3528, SUCCESS WA 6964  
 Tel\Fax: (08)9414 5680  
 Mobile: 0401 612 309  
 E-mail: ausmo2008@hotmail.com


SITE PLAN

JOB No: 1605-skinicare  
 DATE: 16/09/16  
 DRAWN BY: MZ


REV -  
 STG: B

DWG:  
**A03**

- CEILING LIGHT OUTLET
- ◐ SINGLE GPO  
300 (above floor or specified)
- ◑ DOUBLE GPO  
300 (above floor or specified)
- △ PHONE

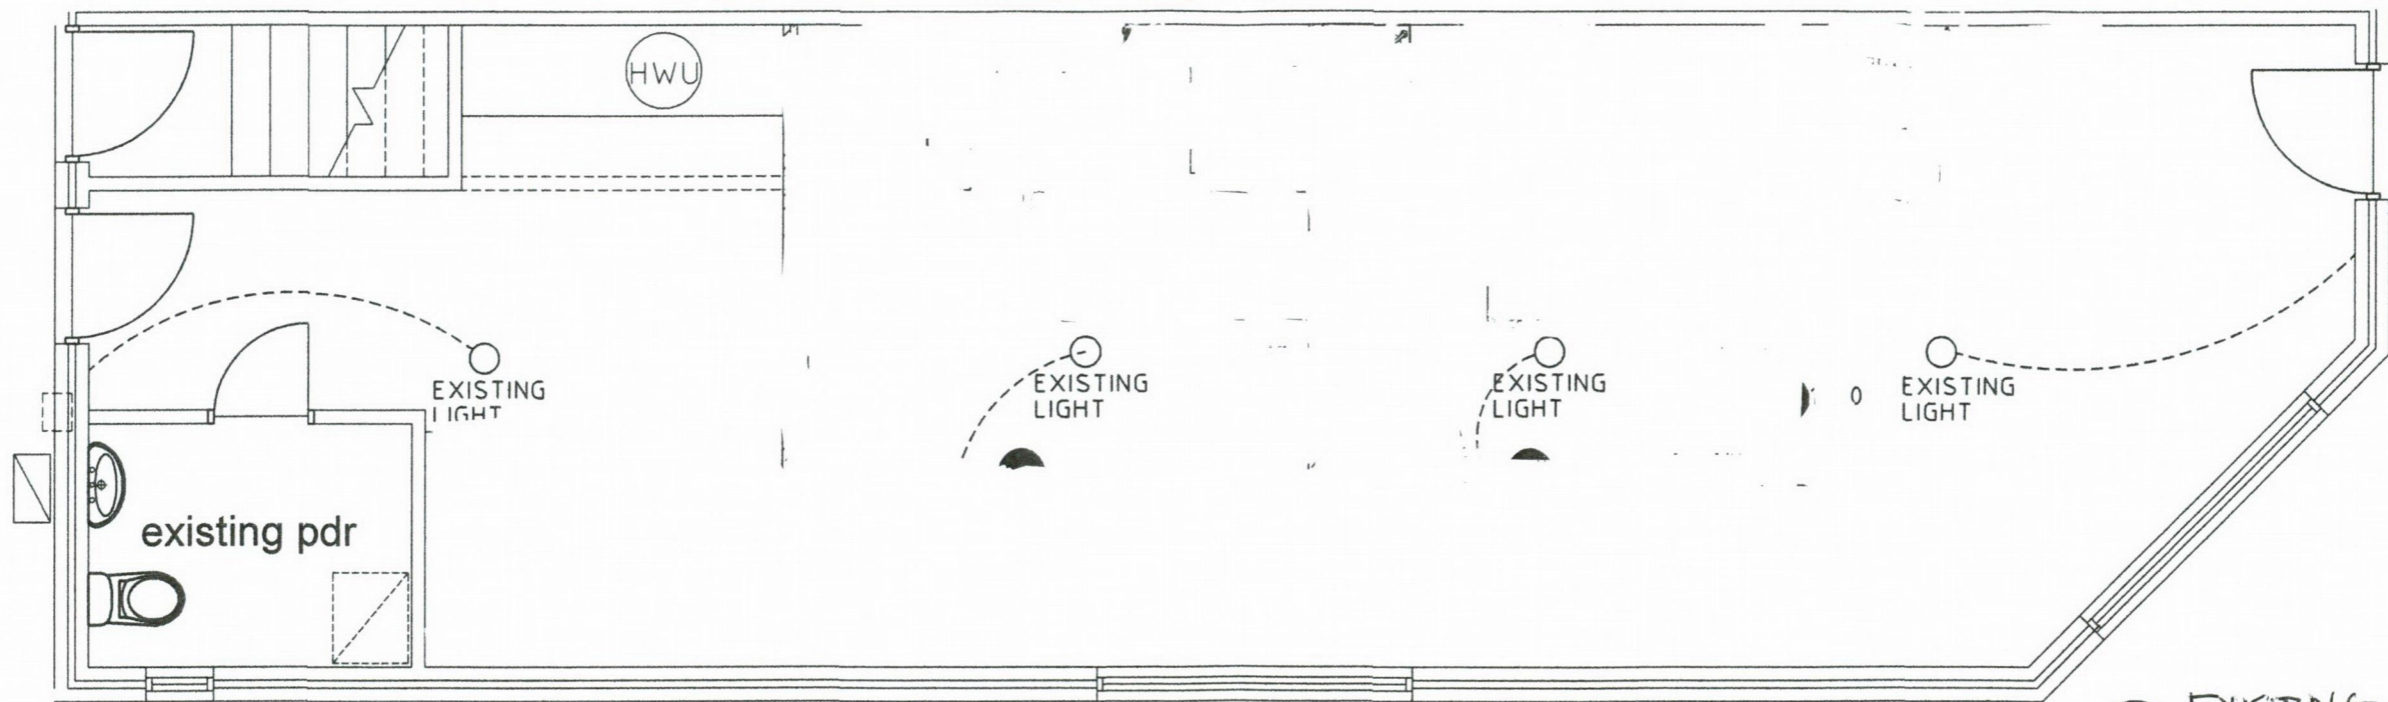

○ EXISTING PLAN  
scale 1:50

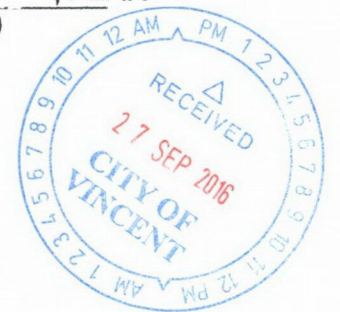

117 / PROPOSED SHOP-FITTING  
shop 7 (LOT12) Brisbane Street, Perth


**MO DESIGN**  
P O BOX 3528, SUCCESS WA 6964  
Tel\Fax: (08)9414 5680  
Mobile: 0401 612 309  
E-mail: ausmo2008@hotmail.com

ELECTRICAL  
LAYOUT

JOB No: 1605-skinicare  
DATE: 27/09/16  
DRAWN BY: MZ

REV	DWG:
-	A02
STG:	
B	

- CEILING LIGHT OUTLET
- ◐ SINGLE GPO  
300 (above floor or specified)
- ◑ DOUBLE GPO  
300 (above floor or specified)
- △ PH  
PHONE

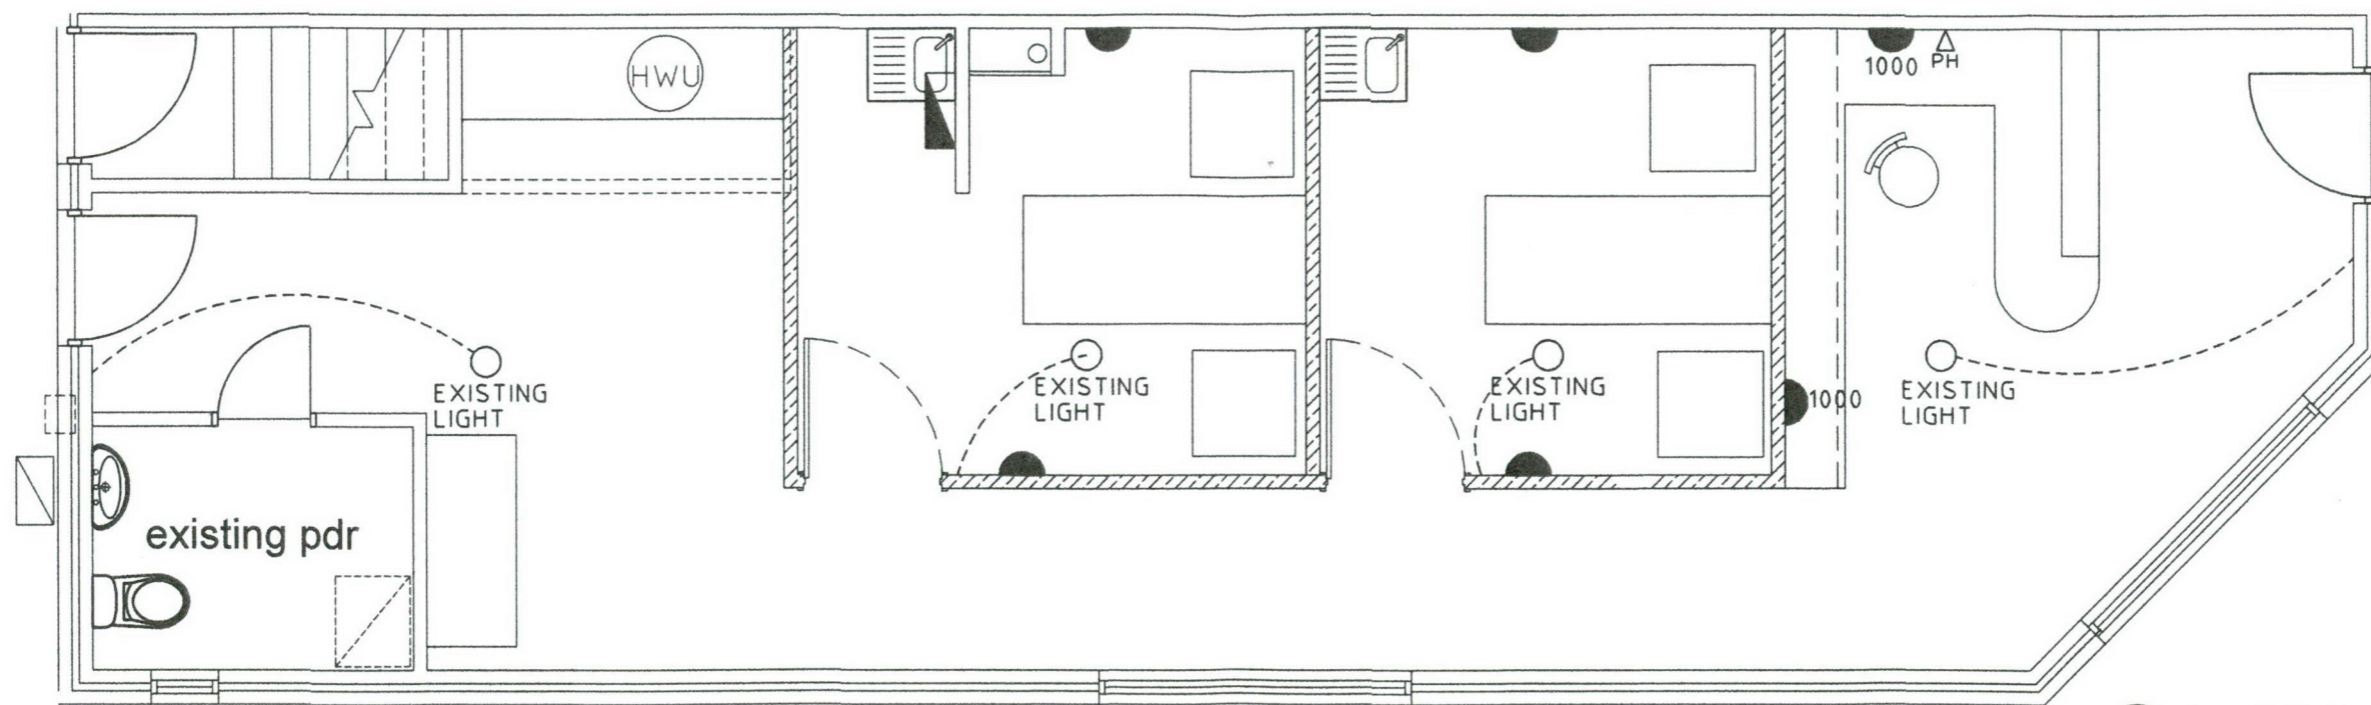

○ ELECTRICAL PLAN  
- scale 1:50




15/17  
PROPOSED SHOP-FITTING  
shop 7 (LOT12) Brisbane Street, Perth  
#117



**MO DESIGN**  
P O BOX 3528, SUCCESS WA 6964  
Tel\Fax: (08)9414 5680  
Mobile: 0401 612 309  
E-mail: ausmo2008@hotmail.com

ELECTRICAL  
LAYOUT


JOB No: 1605-skinicare	REV -	DWG: A02
DATE: 27/09/16	STG: B	
DRAWN BY: MZ		

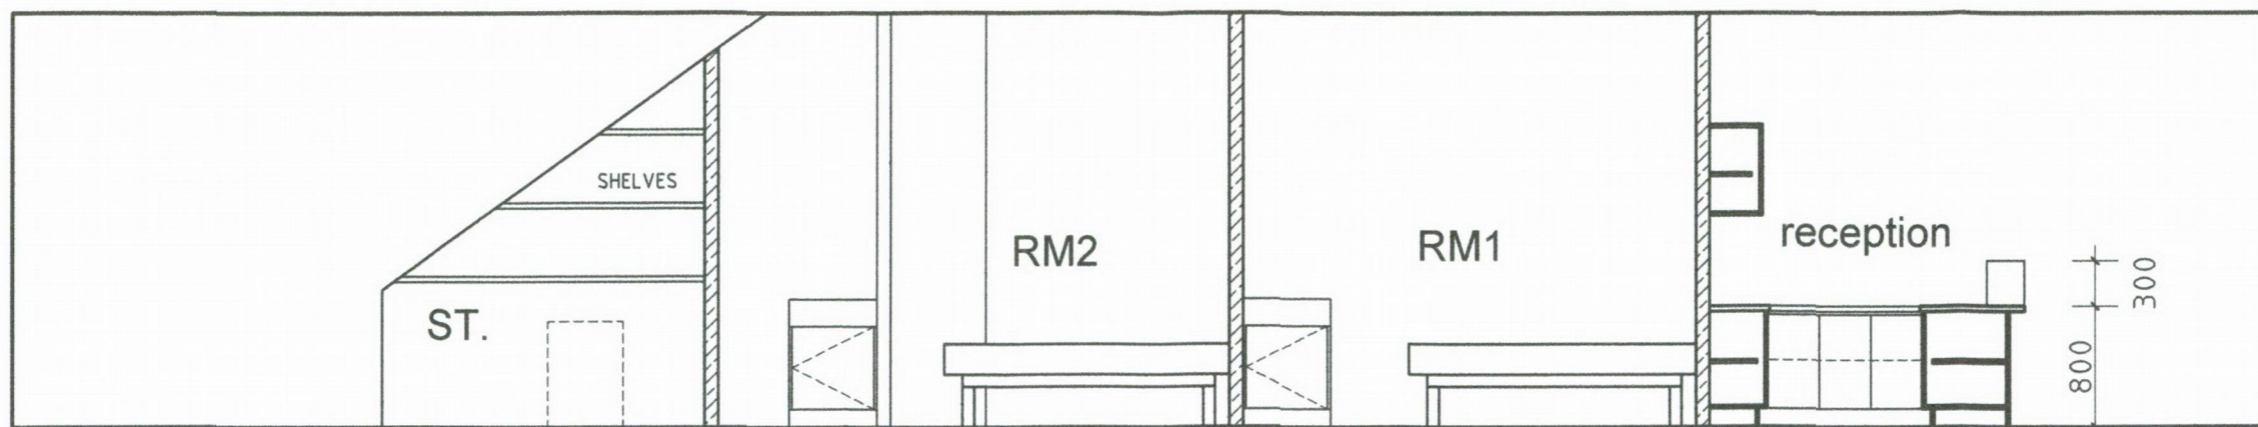

1 ELEVATION  
scale 1:50

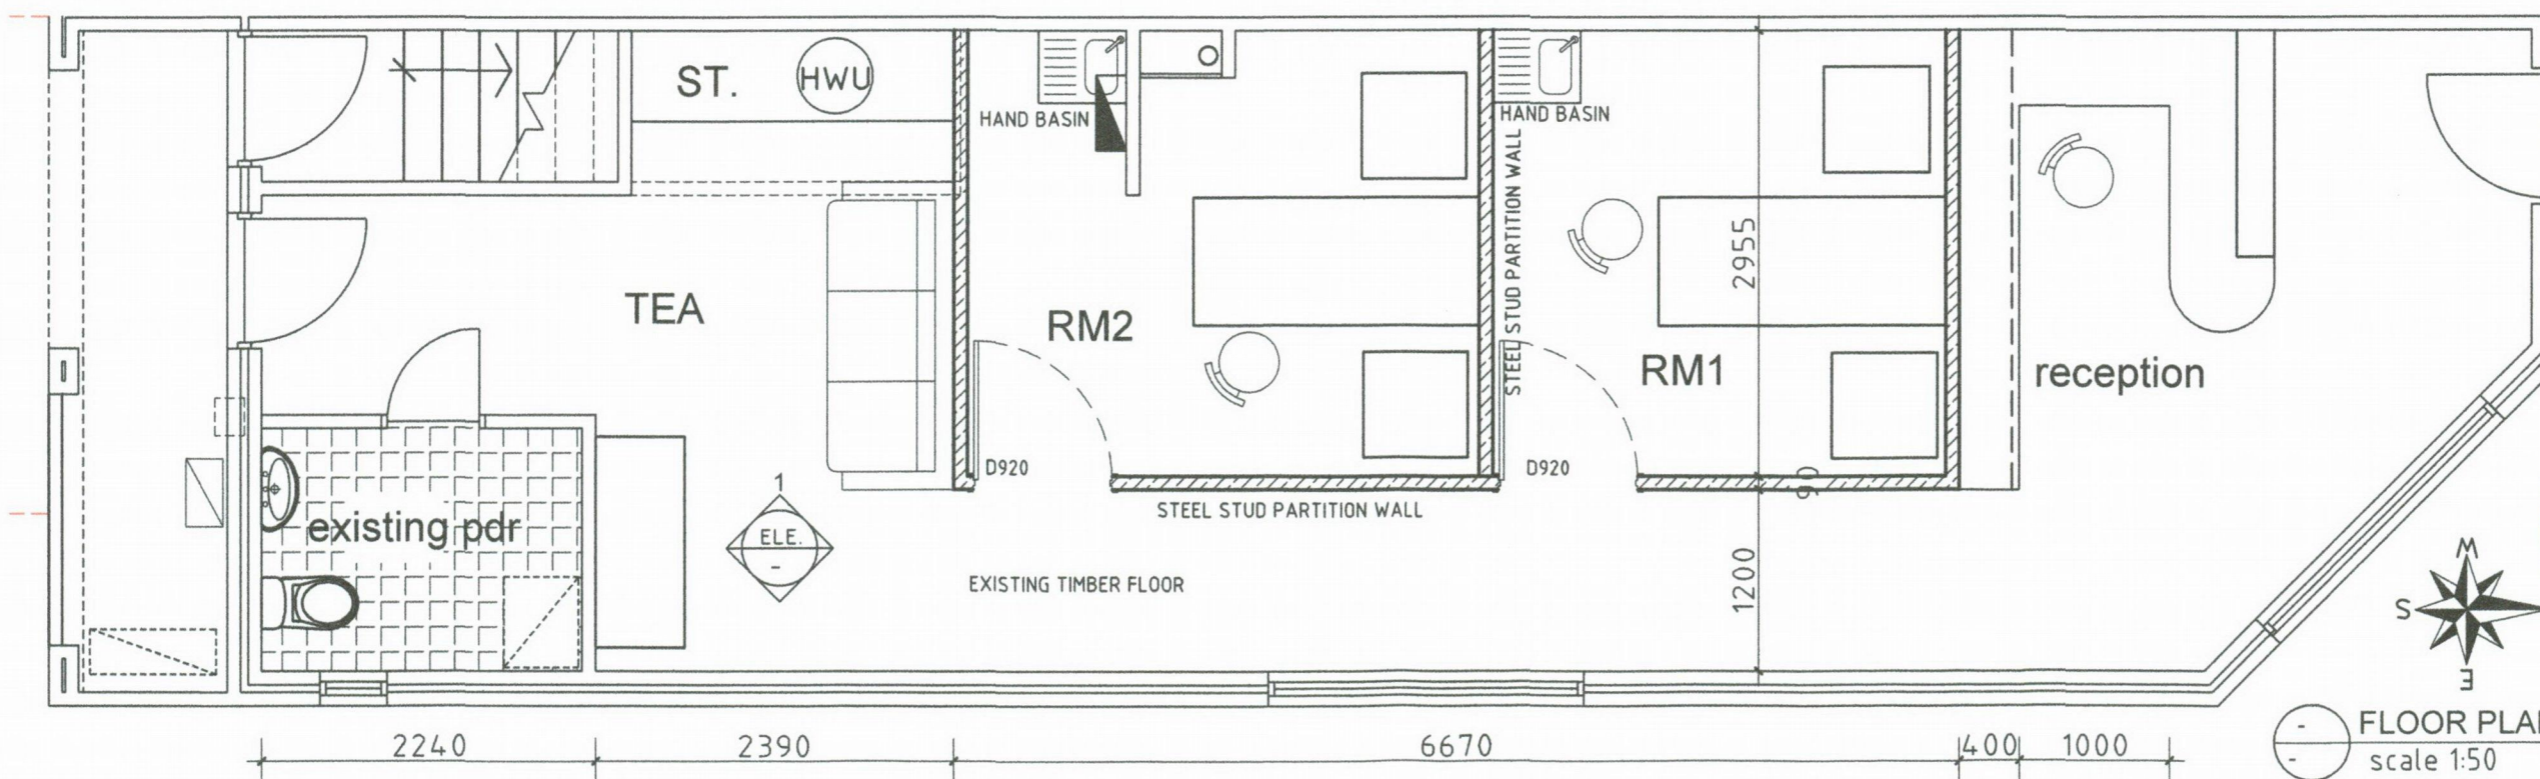 

FLOOR PLAN  
scale 1:50

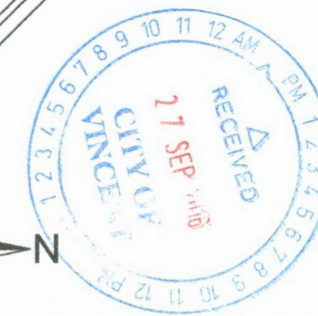

PROPOSED SHOP-FITTING shop 7 (LOT12) Brisbane Street, Perth #117	 <b>MO DESIGN</b> P O BOX 3528, SUCCESS WA 6964 Tel/Fax: (08)9414 5680 Mobile: 0401 612 309 E-mail: ausmo2008@hotmail.com	Plan Elevations	JOB No: 1605-skincare	REV -	DWG:
			DATE: 27/09/16	STG: B	A01
			DRAWN BY: MZ		