

GENERAL NOTES

1. THIS DRAWING IS TO BE READ IN CONJUNCTION WITH AS1742.3 & MRWA COP OCTOBER 2015.
2. ALL TRAFFIC CONTROL DIAGRAMS TO BE READ CONJUNCTION WITH THE TRAFFIC MANAGEMENT DOCUMENT
3. NON-APPLICABLE EXISTING SIGNAGE SHALL BE COVERED EG. SPEED SIGNS DUE TO THE TEMPORARY SPEED ZONE.
4. ALL SIGNAGE DISTANCE SHALL COMPLY WITH AS1742.3 & MRWA COP OCTOBER 2015.
5. IN ACCORDANCE WITH AS1742.3 ACCREDITED TRAFFIC CONTROLLERS TO ASSIST PEDESTRIANS WITH MOVEMENT THROUGH & AROUND THE WORKSITE.
6. SIGNAGE SHALL BE PLACED ON THE SIDE OF THE ROAD ADJACENT TO THE TRAFFIC FLOW, MEDIUM ISLANDS.
7. AS WORK PROGRESSES THE TRAFFIC MANAGEMENT WILL BE DISMANTLED & ADJUSTED TO SUIT THE IMMEDIATE SITE CONDITIONS.

RECOMMENDED TAPER LENGTH

APPROXIMATE SPEED OF TRAFFIC KM/H	TRAFFIC CONTROL AT BEGINNING OF TAPER	LATERAL SHIFT TAPER	MERGE TAPER
45 OR LESS	15	0	15
46-55	15	15	30
56-65	30	30	60
66-75	N/A	70	115
76-85	N/A	80	130
86-95	N/A	90	145
96-105	N/A	100	160
> 105	N/A	110	180

DIMENSION "D"

SPEED OF TRAFFIC KM/H	DIMENSION "D" M
45 OR LESS	15M
46-55	15M
56-65	45M
GREATER THAN 65KM/H	EQUAL TO SPEED POSTED


TOLERANCES

POSITIONING OF SIGNS
MINIMUM 10% LESS THAN
THE DISTANCE OR LENGTHS GIVEN
MAXIMUM 25% MORE THAN THE
DISTANCE OR LENGTHS GIVEN
SPACING
OF DELINEATING DEVICES
MAXIMUM 10% MORE THAN THE SPACES
GIVEN
NO MINIMUM

LANE WIDTHS

THE MIN LANE WIDTH TO BE PROVIDED
THROUGH OR PAST THE WORKSITE
SHALL BE 3.0M AT TRAFFIC SPEEDS UP TO
50KM/H & 3.2 AT 60KM/H. A
WIDER LANE WIDTH IS REQUIRED AT CURVES.

Event Area

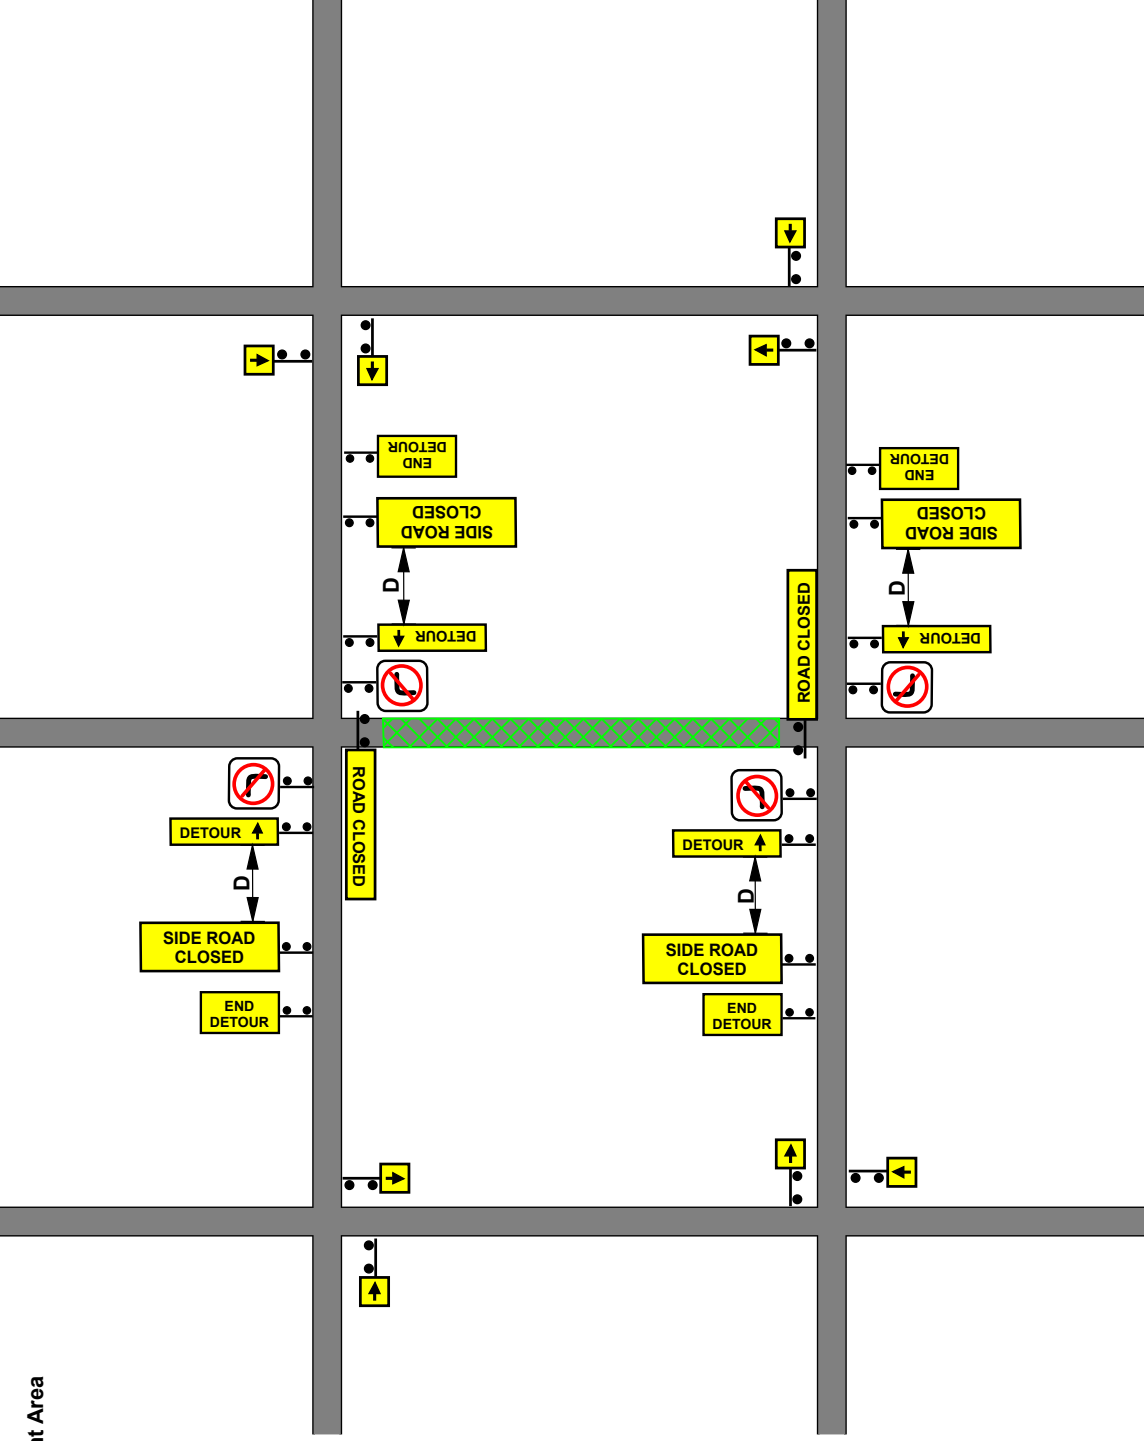

CLIENT:

TITLE:
General Road Closure Layout - Block
Closure with Detour

TEMPORARY SPEEDS

WORKERS OR PLANT OPERATING WITHIN 1.2M OF TRAFFIC LANE LENGTH - MAX 500M 60KM/H
WORKERS OR PLANT OPERATING WITHIN 1.2M OF TRAFFIC LANE SHALL BE AT LEAST 150M LONG 60KM/H
WORKERS OR PLANT OPERATING BETWEEN 3.0M OF TRAFFIC LANE LENGTH 500M MIN 60KM/H

vigilant
TRAFFIC MANAGEMENT

DATE:	DRAWN BY:	ACCREDITATION:	SIGNATURE:
21/08/2018	HARRISON SMITH	15-40857-01	
POSTED SPEED:	DESIGNED BY:	ACCREDITATION:	SIGNATURE:
	HARRISON SMITH	15-40857-01	
WORKSITE SPEED:	CHECKED BY:	ACCREDITATION:	SIGNATURE:
	SHANE SMITH	14-07930-01	